
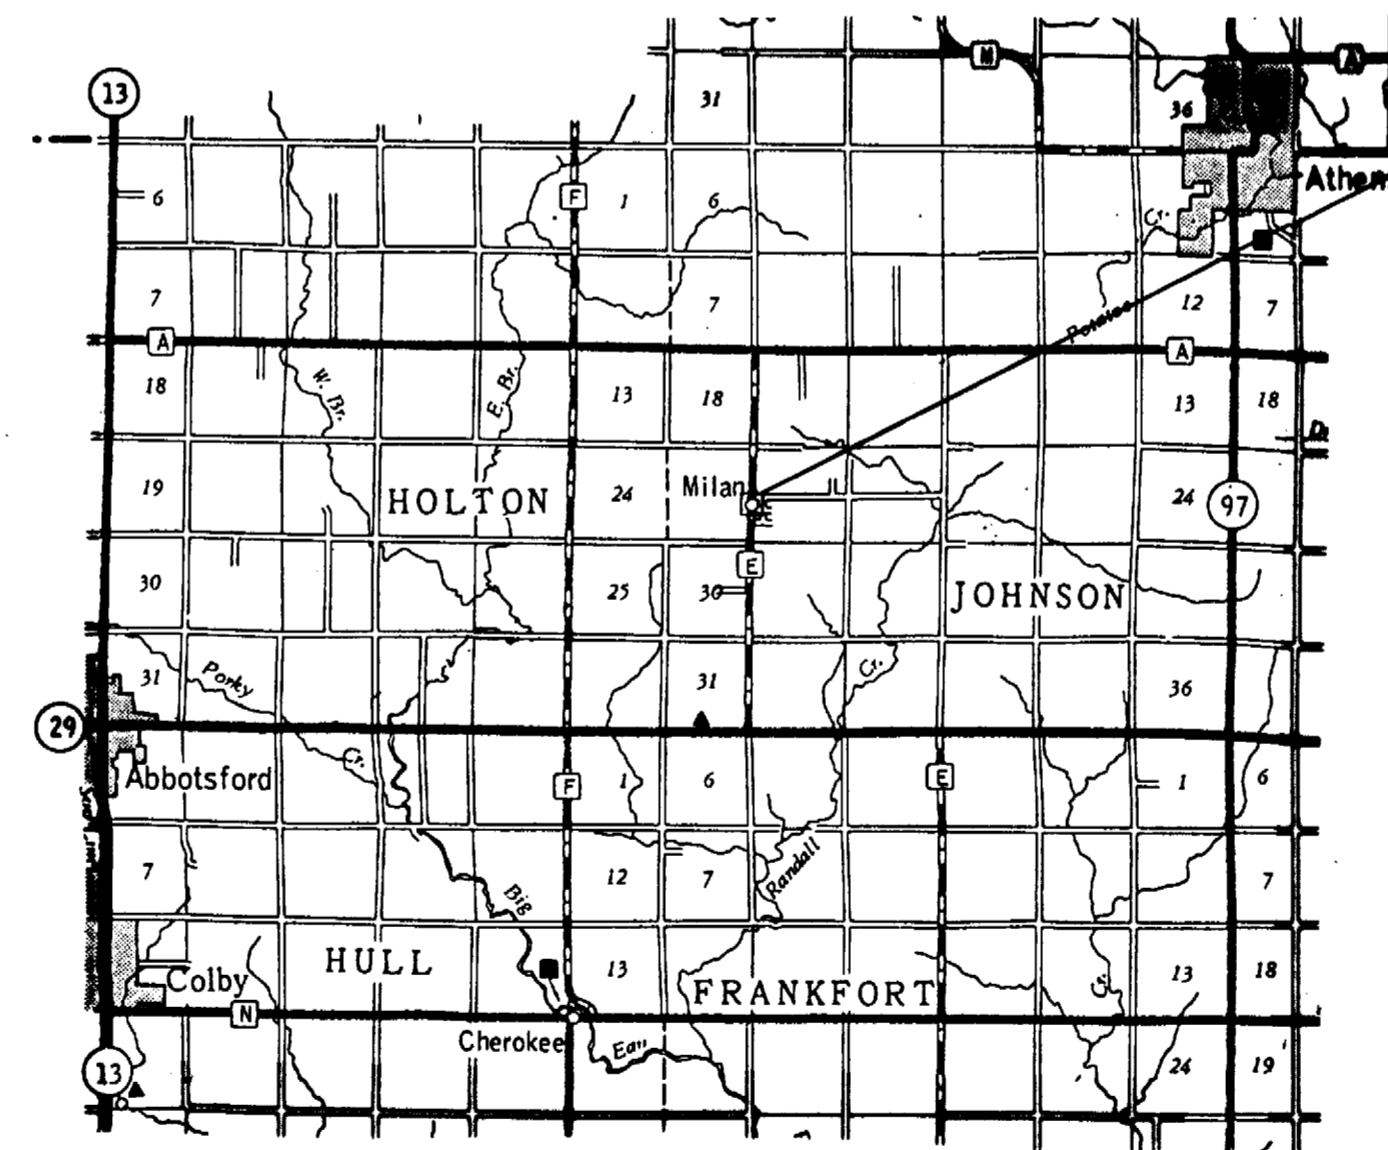



MARATHON COUNTY HIGHWAY DEPARTMENT PLAN AND PROFILE OF PROPOSED C.T.H. "E" (MILAN)

HOLTON	BERN	HALSEY	HAMBURG	BERLIN	MAINE	TEXAS	HEWITT	WARRISON
HULL	SPRISON	RETTBROOK	RID FALLS	STETTIN	WISLAU	EASTON	FLOWER	
BRIGHTON	FRANKFORT	VEIN	CASSEL	MARATHON	RID. WY.	VESTON	RINGLE	HORRIE
SPENCER	MCALLAN	DAY	GREEN VALLEY	BERGEN	WADSWORTH	QUENTNER	BEYER	FRANZEN

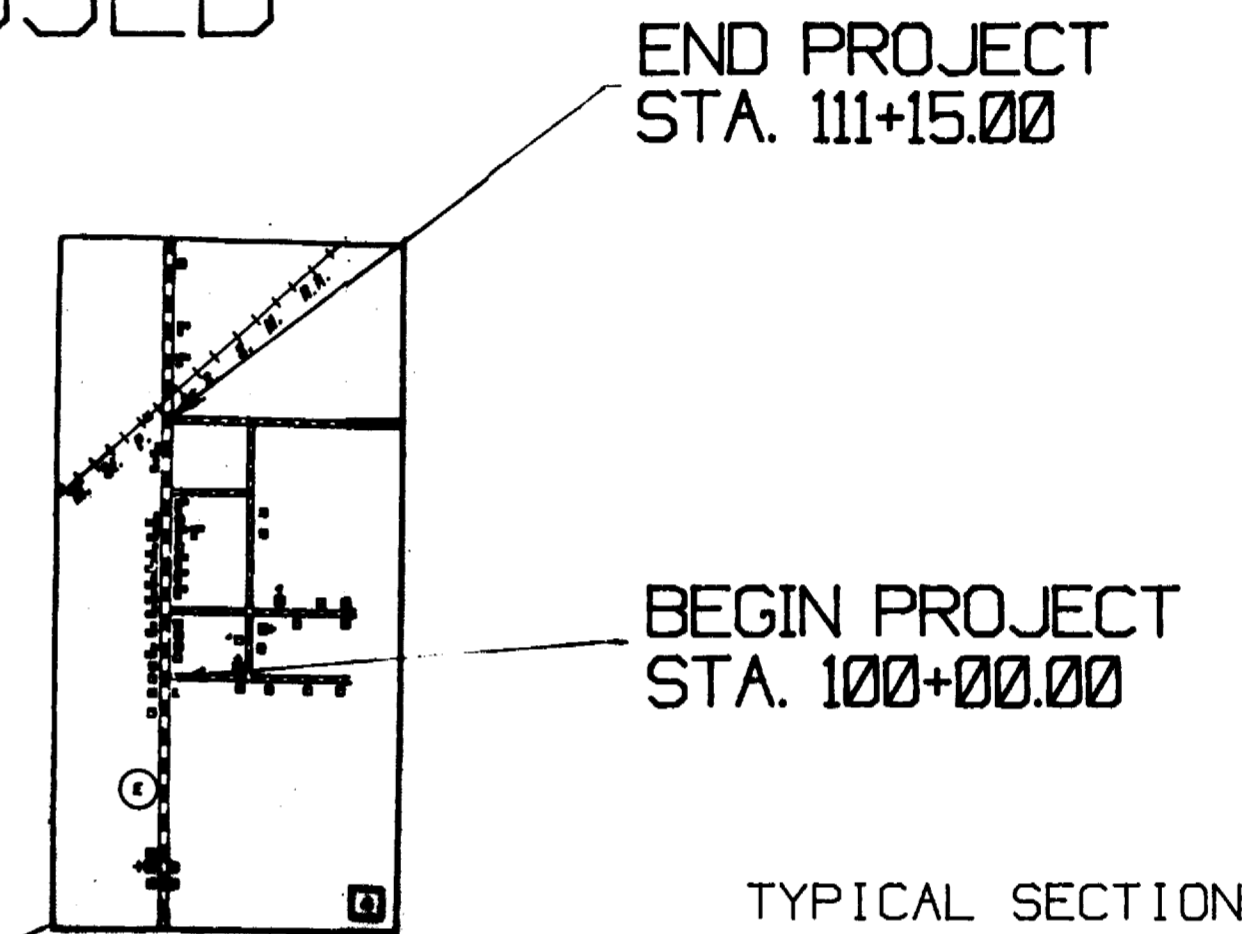

LEGEND

NEW RIGHT-OF-WAY	—————
PRESENT RIGHT-OF-WAY	-----
PROPERTY LINE	----- P.L. -----
WELL	⊞
TELEPHONE CABLE	— T — T — T —
POWER CABLE	— P — P — P —
GAS LINE	— G — G — G —
POWER POLE	⊠
TELEPHONE POLE	⊠
TELEPHONE PEDESTAL	⊠
GUY POLE	⊠
TRANSMISSION TOWER & LINE	— X —
FENCE	— x — x — x —
TRAVELED WAY	=====

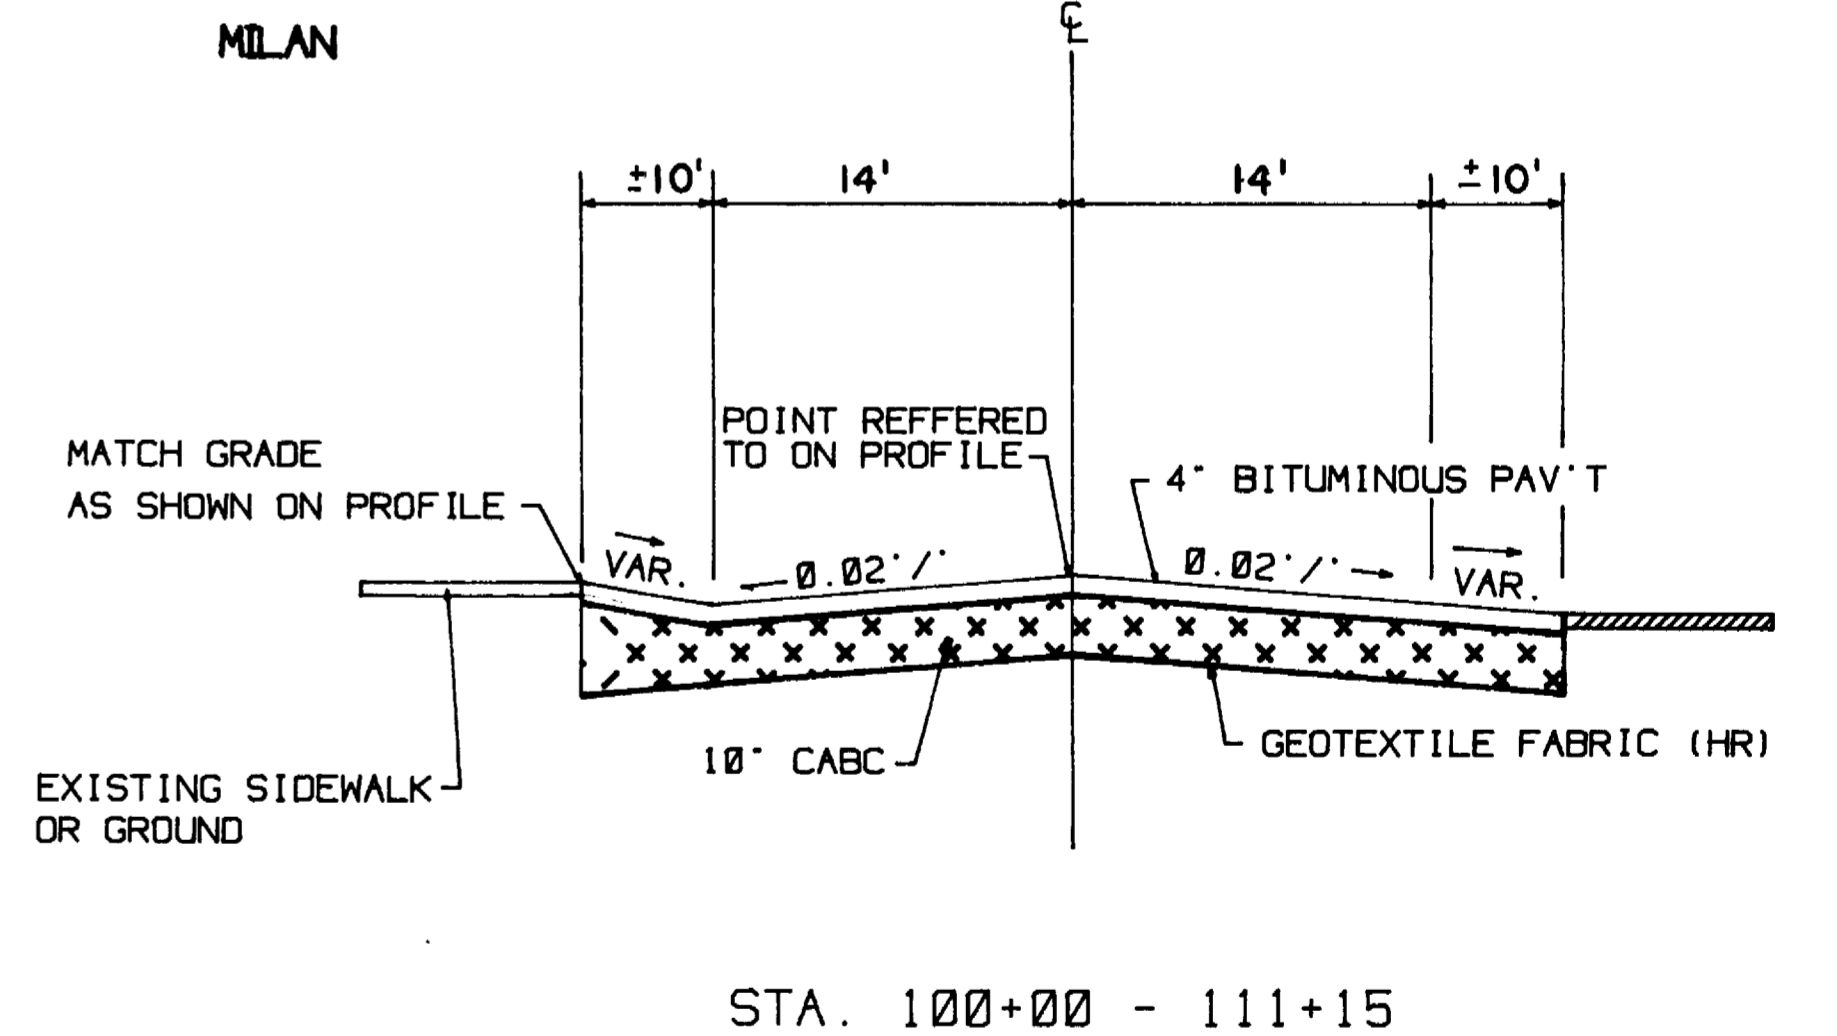

SCALE = 1"=50'

NET LENGTH OF CENTERLINE = 8211 MI. (URBAN)

